

Do Not Scale off the Drawings
 Verify all Dimensions and Levels on Site prior to
 Commencing work
 Copyright Unitec © 2011


| Rev. | Description | Date |
|------|-------------|------|
| | | |

project
Waterview Fire Station
 29-37 Davenport Street
 Wateview

sheet
Level 1 Floor Plan



| date | drawn | job |
|---------------------------------|----------|------------------|
| April 2011 | DS | 1150 |
| scale @ A1 = 1 : 50 | | (A3 = scale x 2) |
| sheet status Information | | |
| sheet number | revision | |
| A22 | - | |

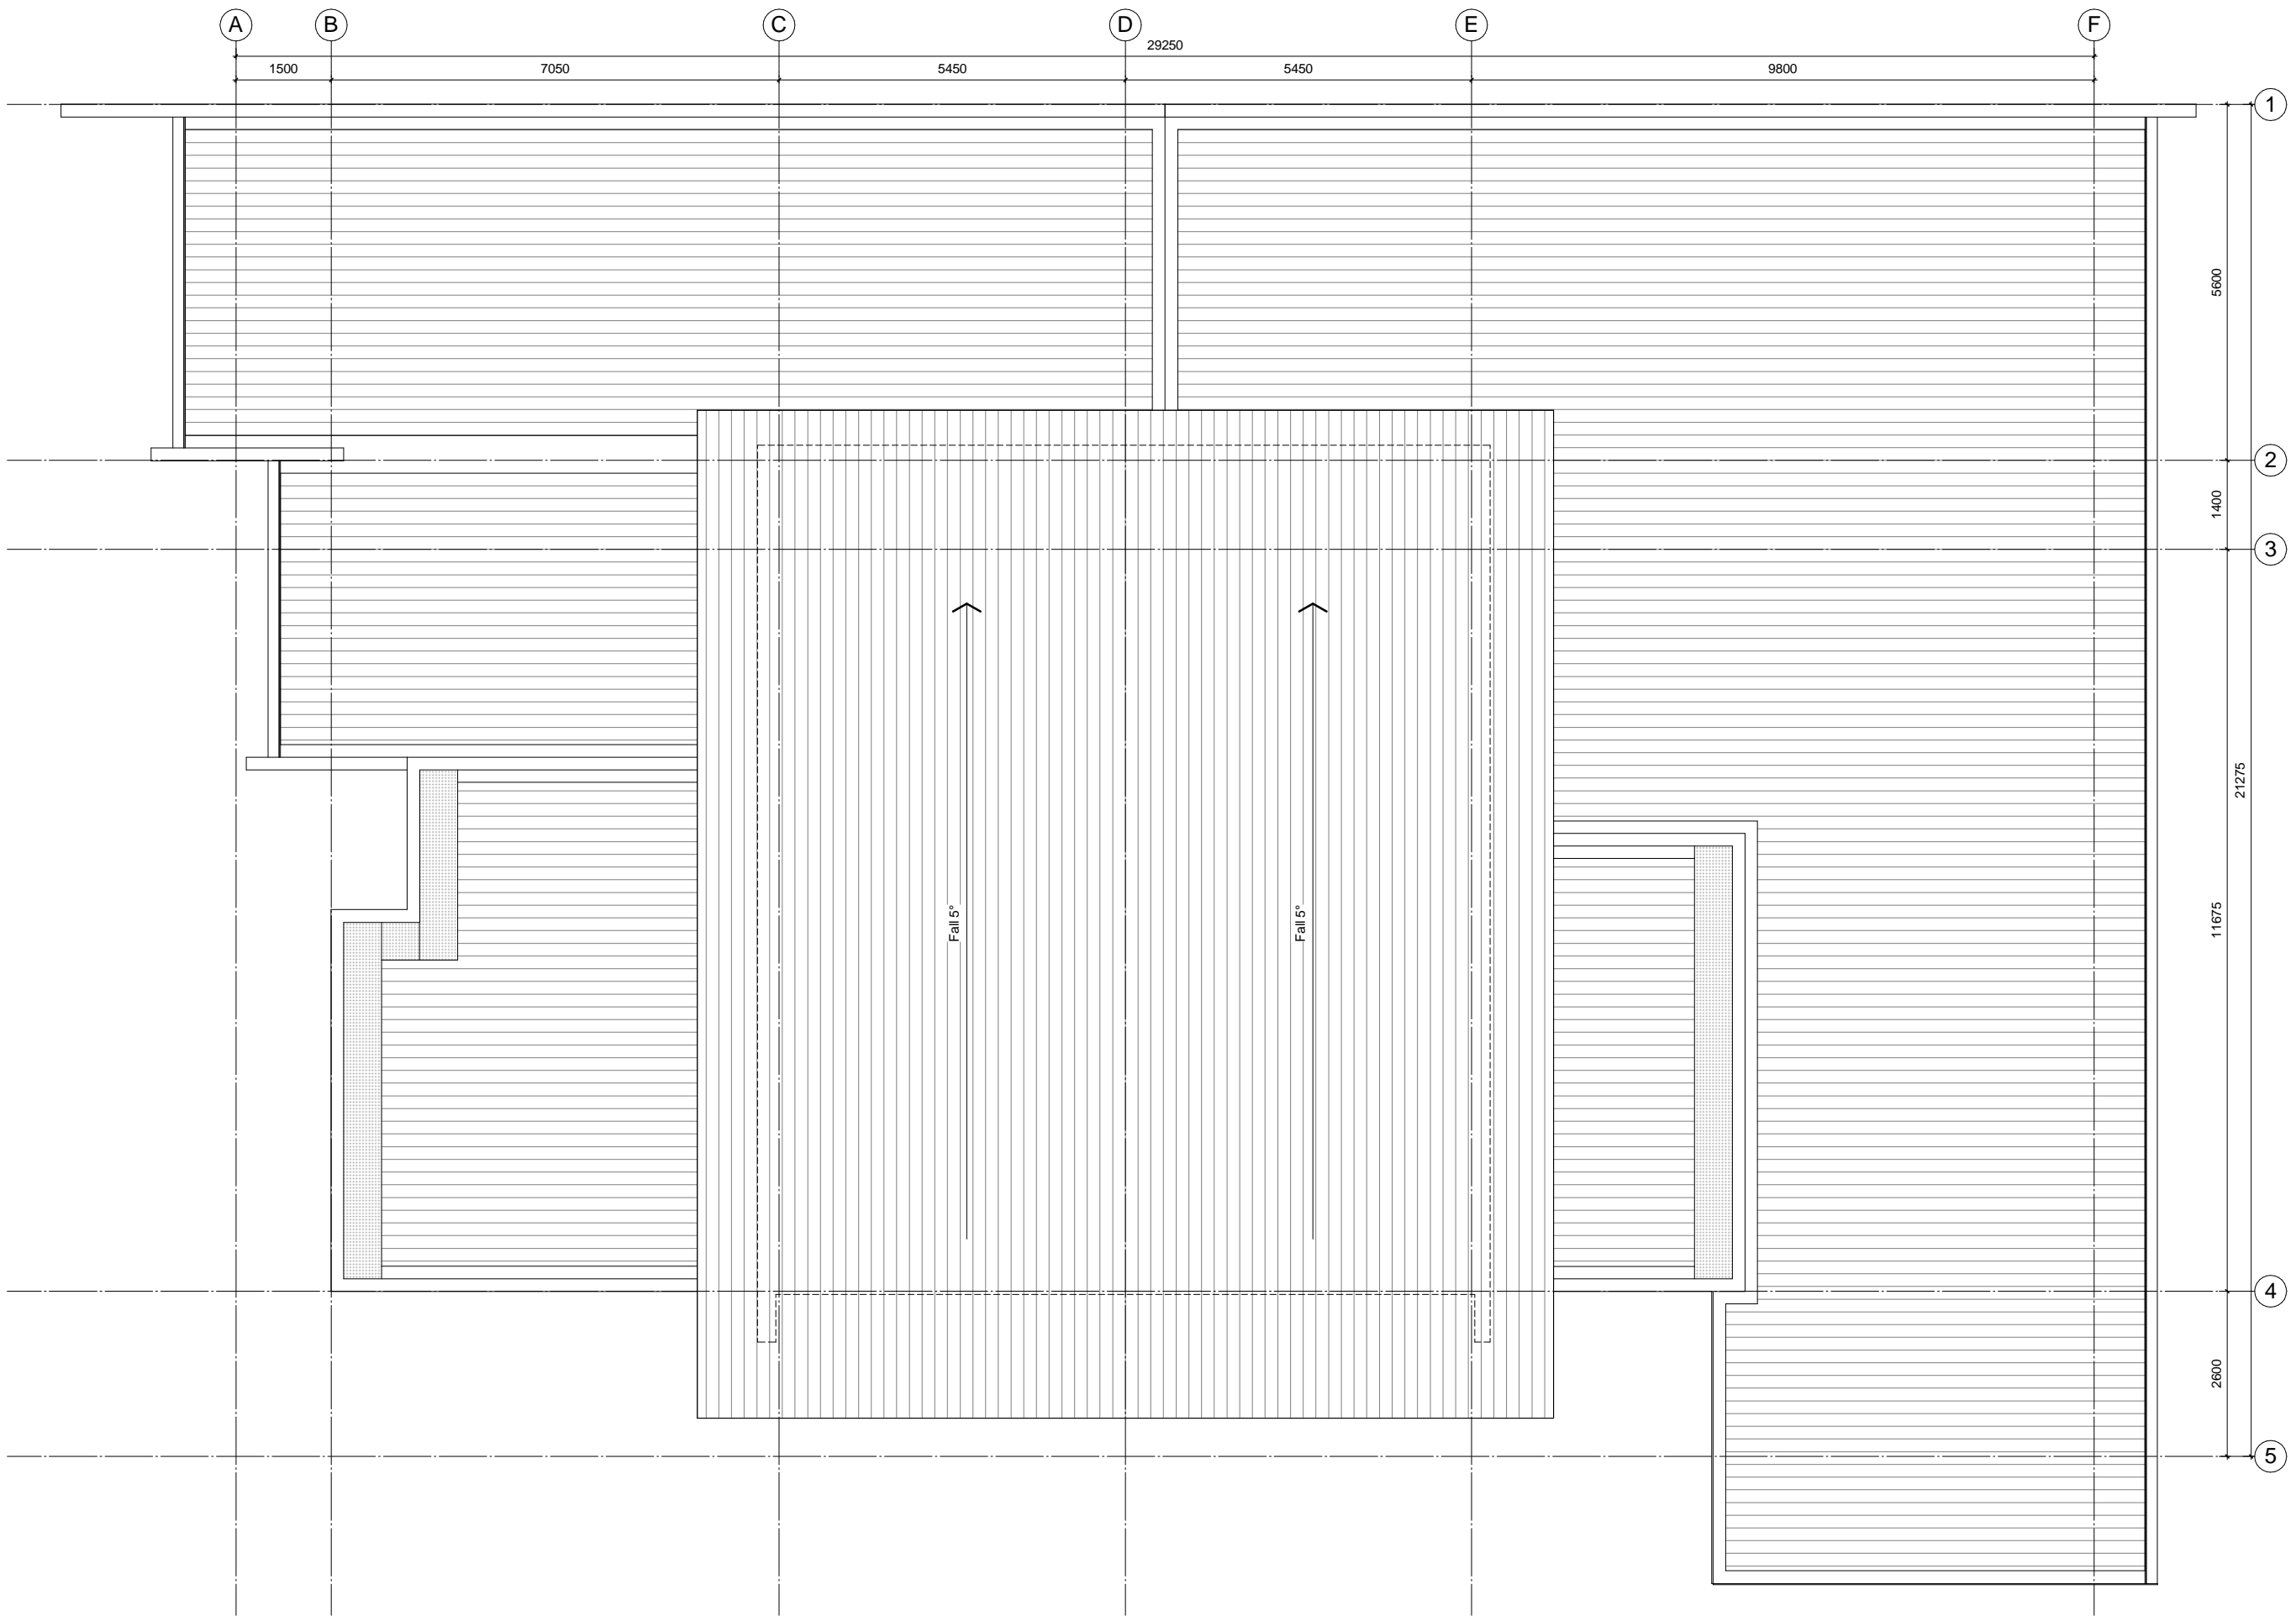

Do Not Scale off the Drawings
 Verify all Dimensions and Levels on Site prior to
 Commencing work
 Copyright Unitec © 2011


| Rev. | Description | Date |
|------|-------------|------|
| | | |

project
Waterview Fire Station
 29-37 Davenport Street
 Waterview


sheet
Roof Plan



| date | drawn | job |
|--------------------------------------|----------|------|
| April 2011 | DS | 1150 |
| scale @ A1 = 1 : 50 (A3 = scale x 2) | | |
| sheet status Information | | |
| sheet number | revision | |
| A23 | - | |

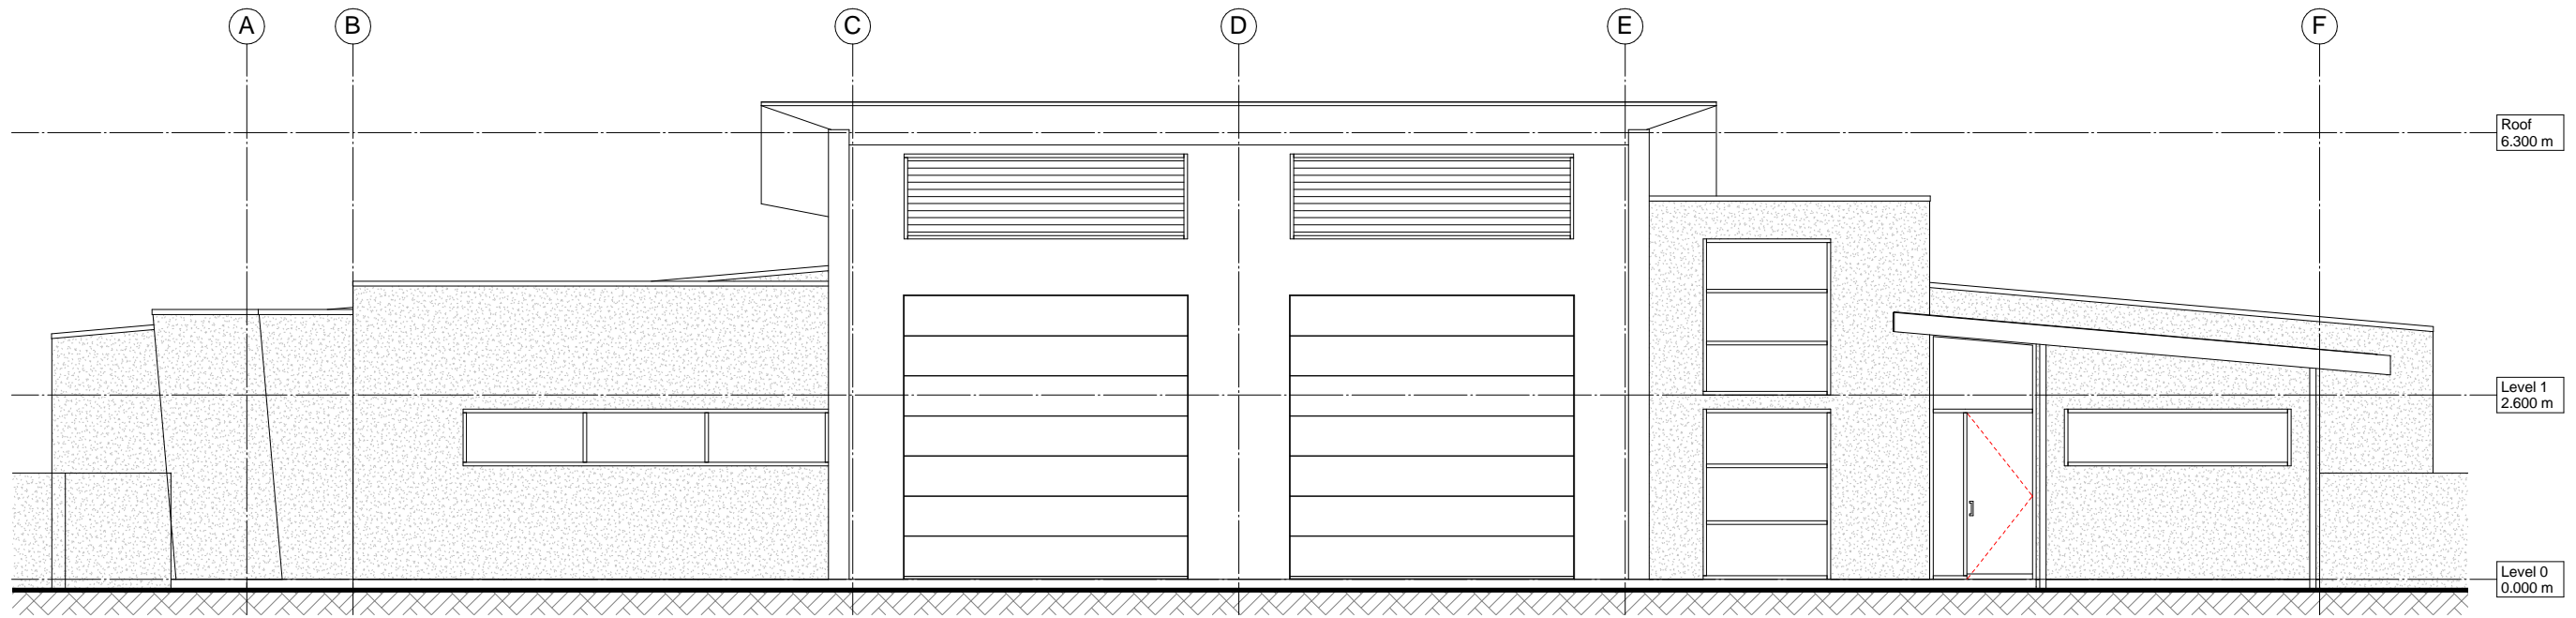

1 Elevation 1 - South
A21 1:50

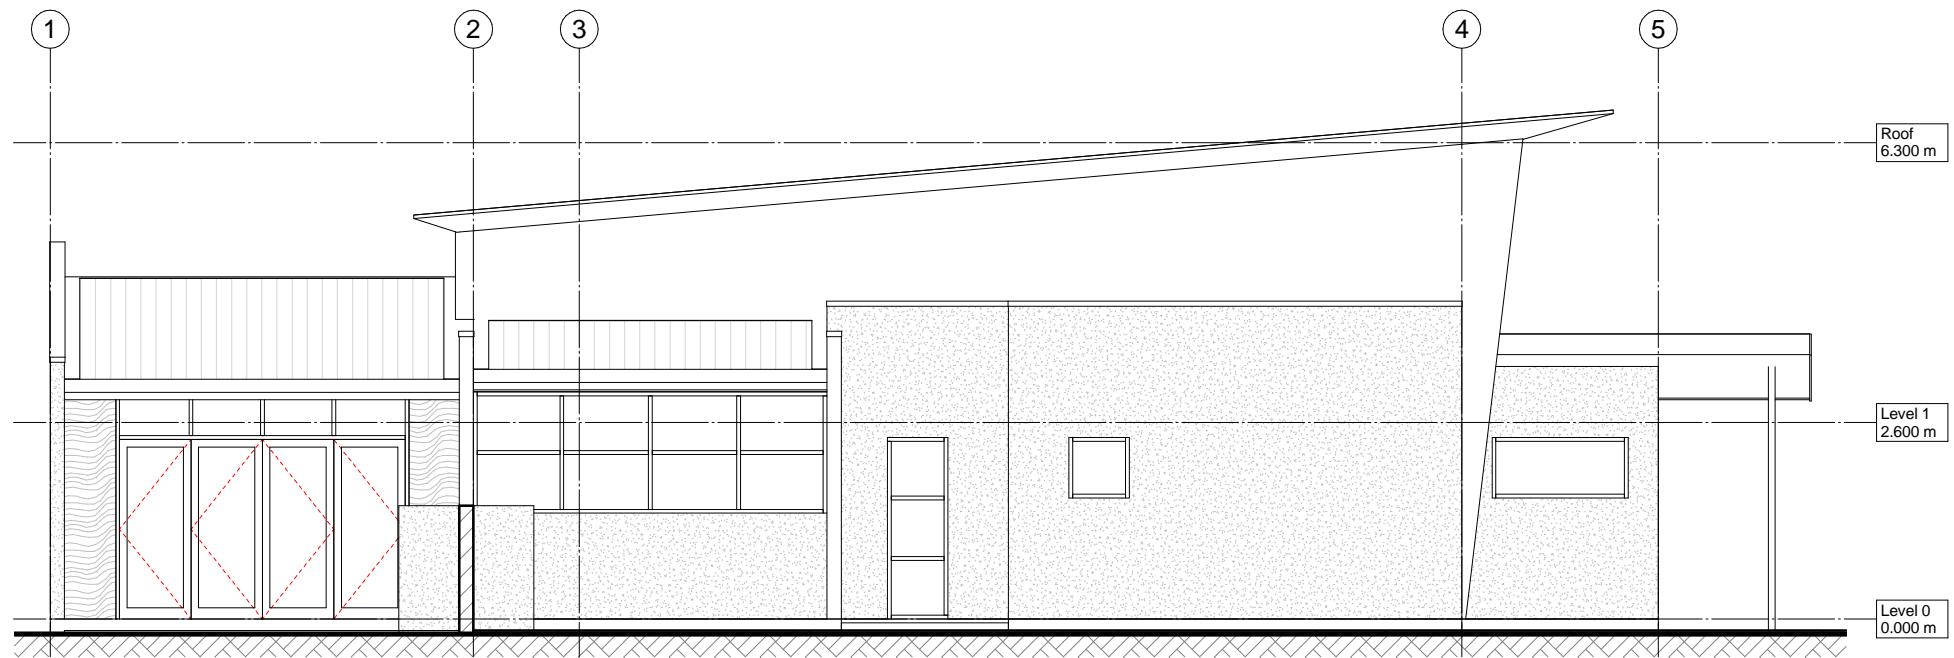

2 Elevation 2 - West
A21 1:50

Do Not Scale off the Drawings
Verify all Dimensions and Levels on Site prior to
Commencing work
Copyright Unitec © 2011


| Rev. | Description | Date |
|------|-------------|------|
| | | |

project
Waterview Fire Station
29-37 Daventry Street
Waterview


sheet
Elevations



| date | drawn | job |
|-------------------|----------|------------------|
| April 2011 | DS | 1150 |
| scale @ A1 = 1:50 | | (A3 = scale x 2) |
| sheet status | | Information |
| sheet number | revision | |
| A31 | - | |

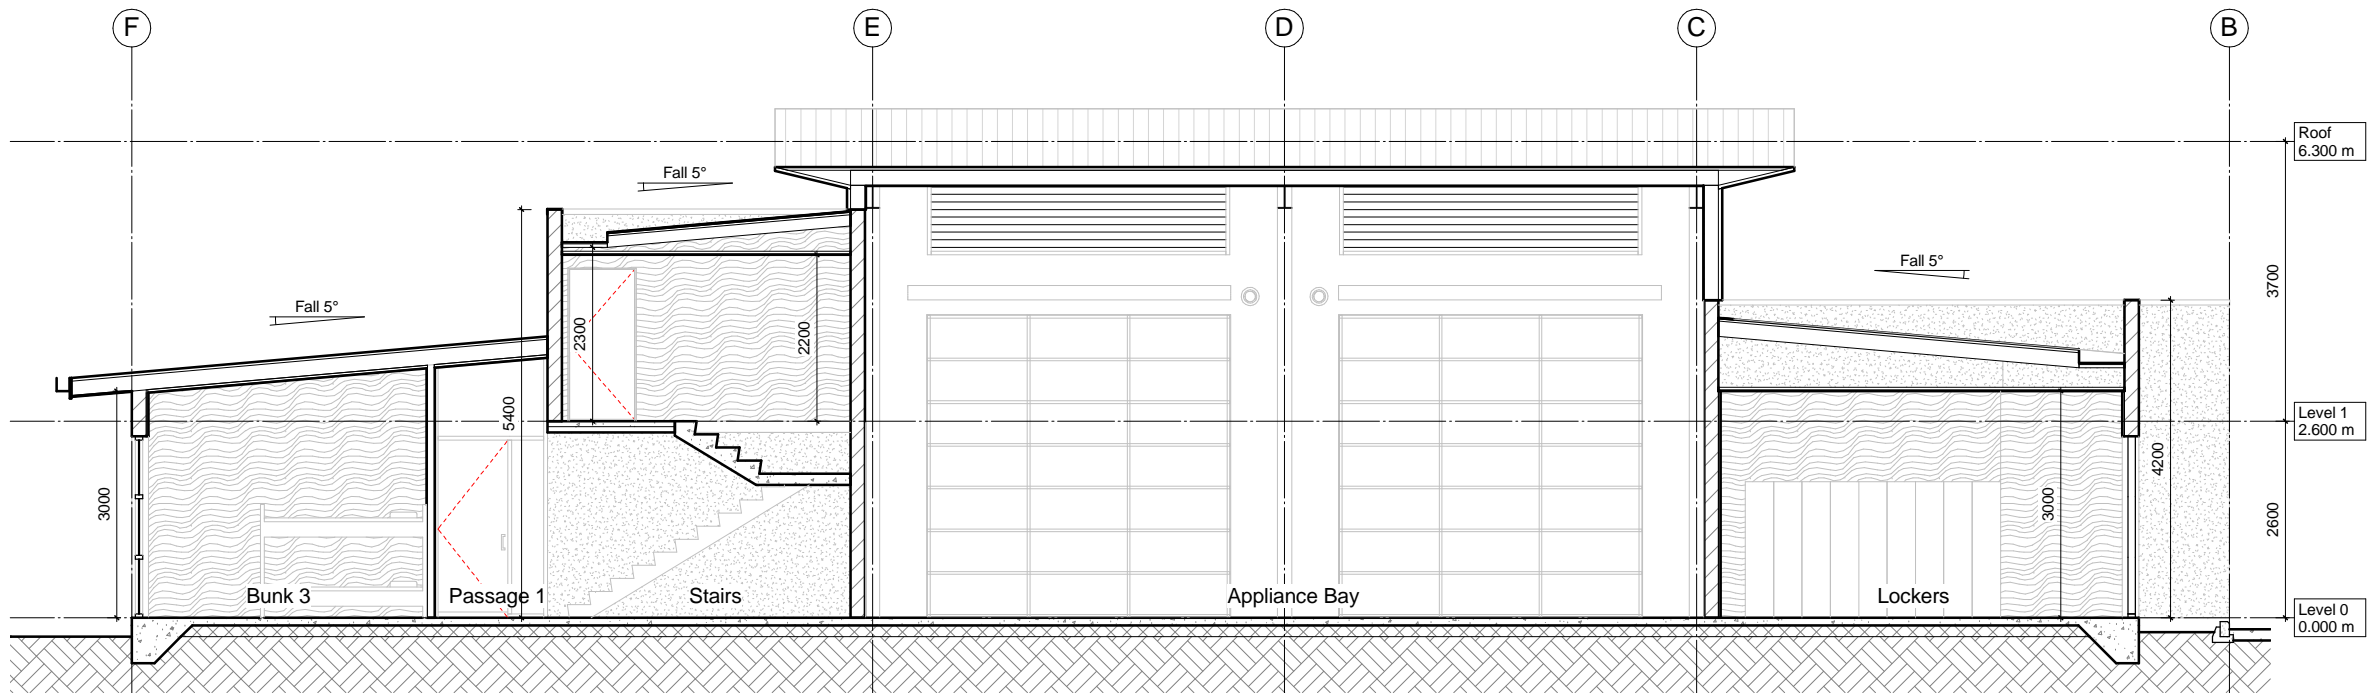

A Section A
A21 1:50

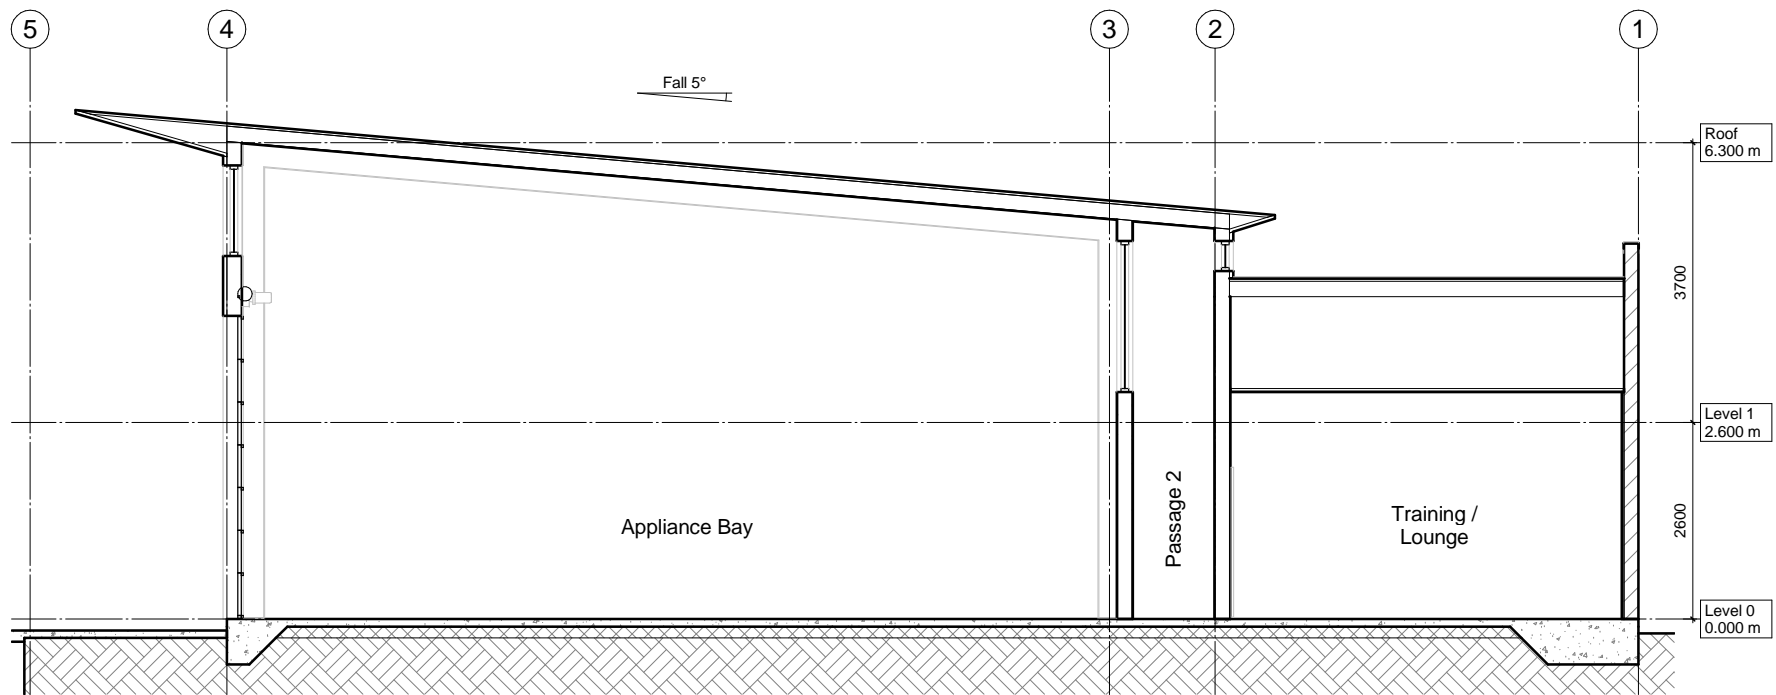

B Section B
A21 1:50

Do Not Scale off the Drawings
Verify all Dimensions and Levels on Site prior to
Commencing work
Copyright Unitec © 2011

| Rev. | Description | Date |
|------|-------------|------|
| | | |


project
Waterview Fire Station

29-37 Davenport Street
Waterview

sheet
Sections



| date | drawn | job |
|---------------------------------|----------|------------------|
| April 2011 | DS | 1150 |
| scale @ A1 = 1:50 | | (A3 = scale x 2) |
| sheet status Information | | |
| sheet number | revision | |
| A41 | - | |

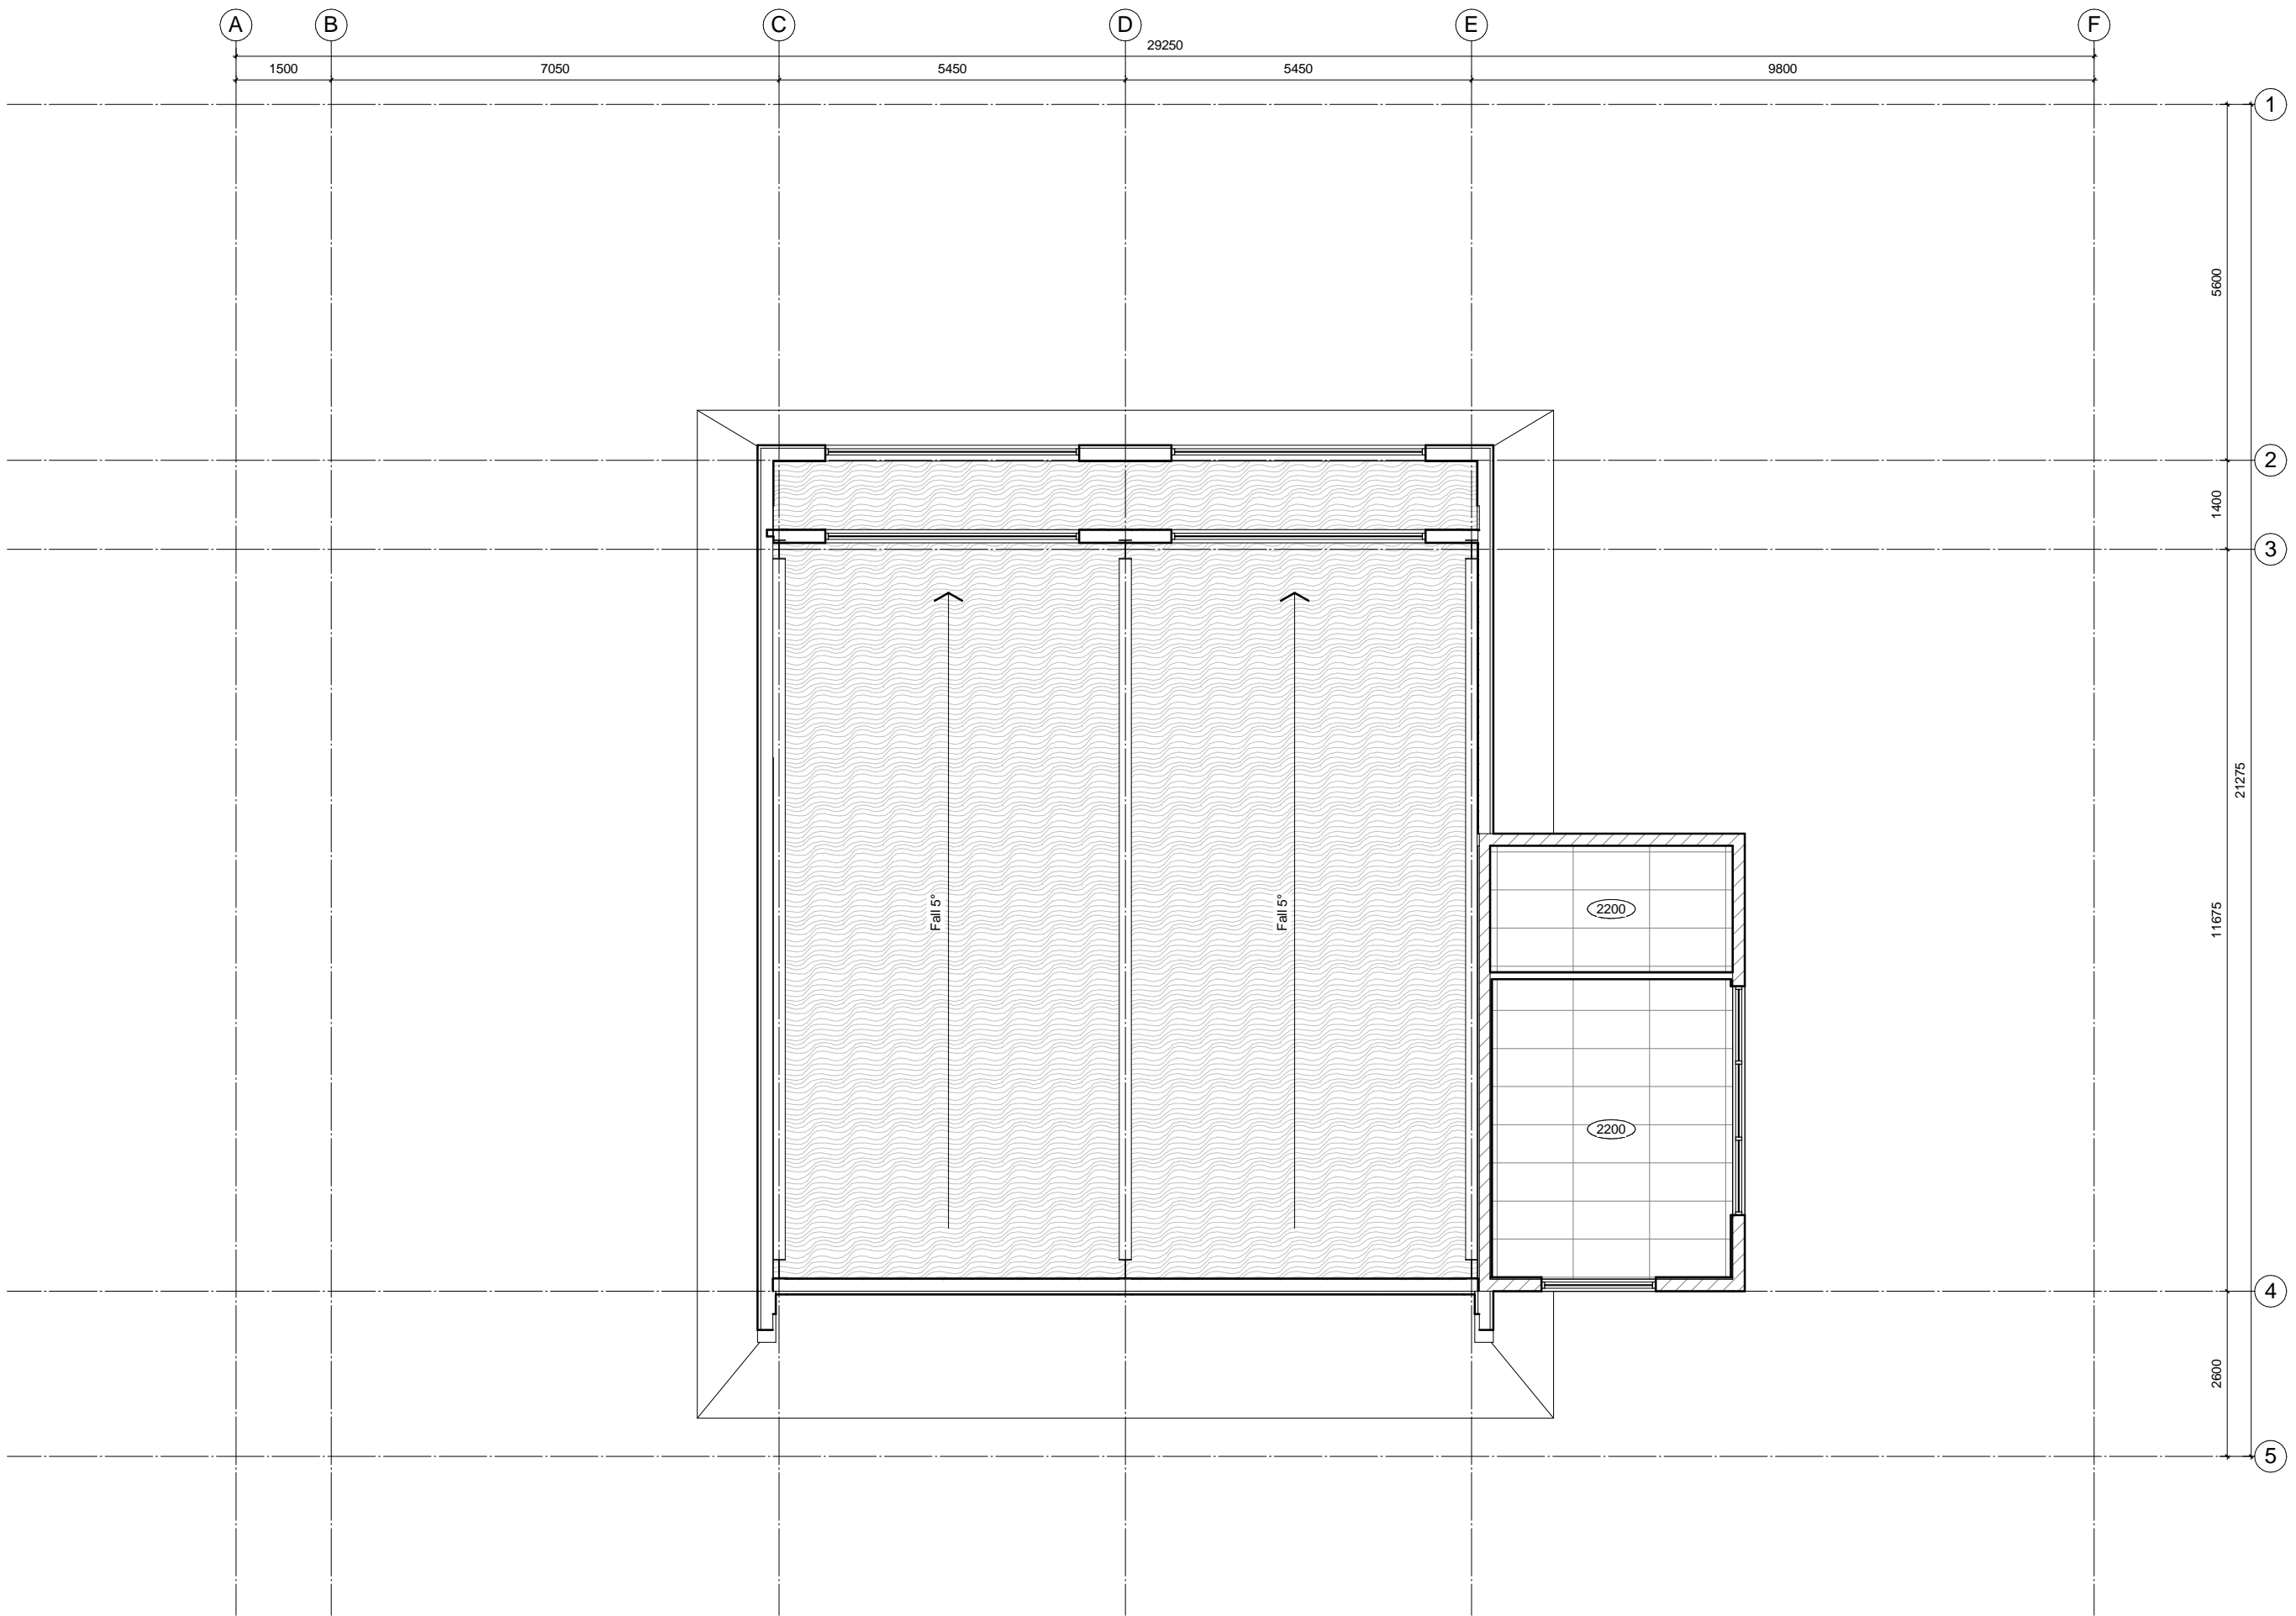

Do Not Scale off the Drawings
 Verify all Dimensions and Levels on Site prior to
 Commencing work
 Copyright Unitec © 2011

| Rev. | Description | Date |
|------|-------------|------|
| | | |

project
Waterview Fire Station
 29-37 Davenport Street
 Waterview

sheet
Ceiling Plan Level 1



| date | drawn | job |
|--------------------------------------|----------|------|
| April 2011 | DS | 1150 |
| scale @ A1 = 1 : 50 (A3 = scale x 2) | | |
| sheet status Information | | |
| sheet number | revision | |
| A62 | - | |