


ISOMETRIC VIEW 1

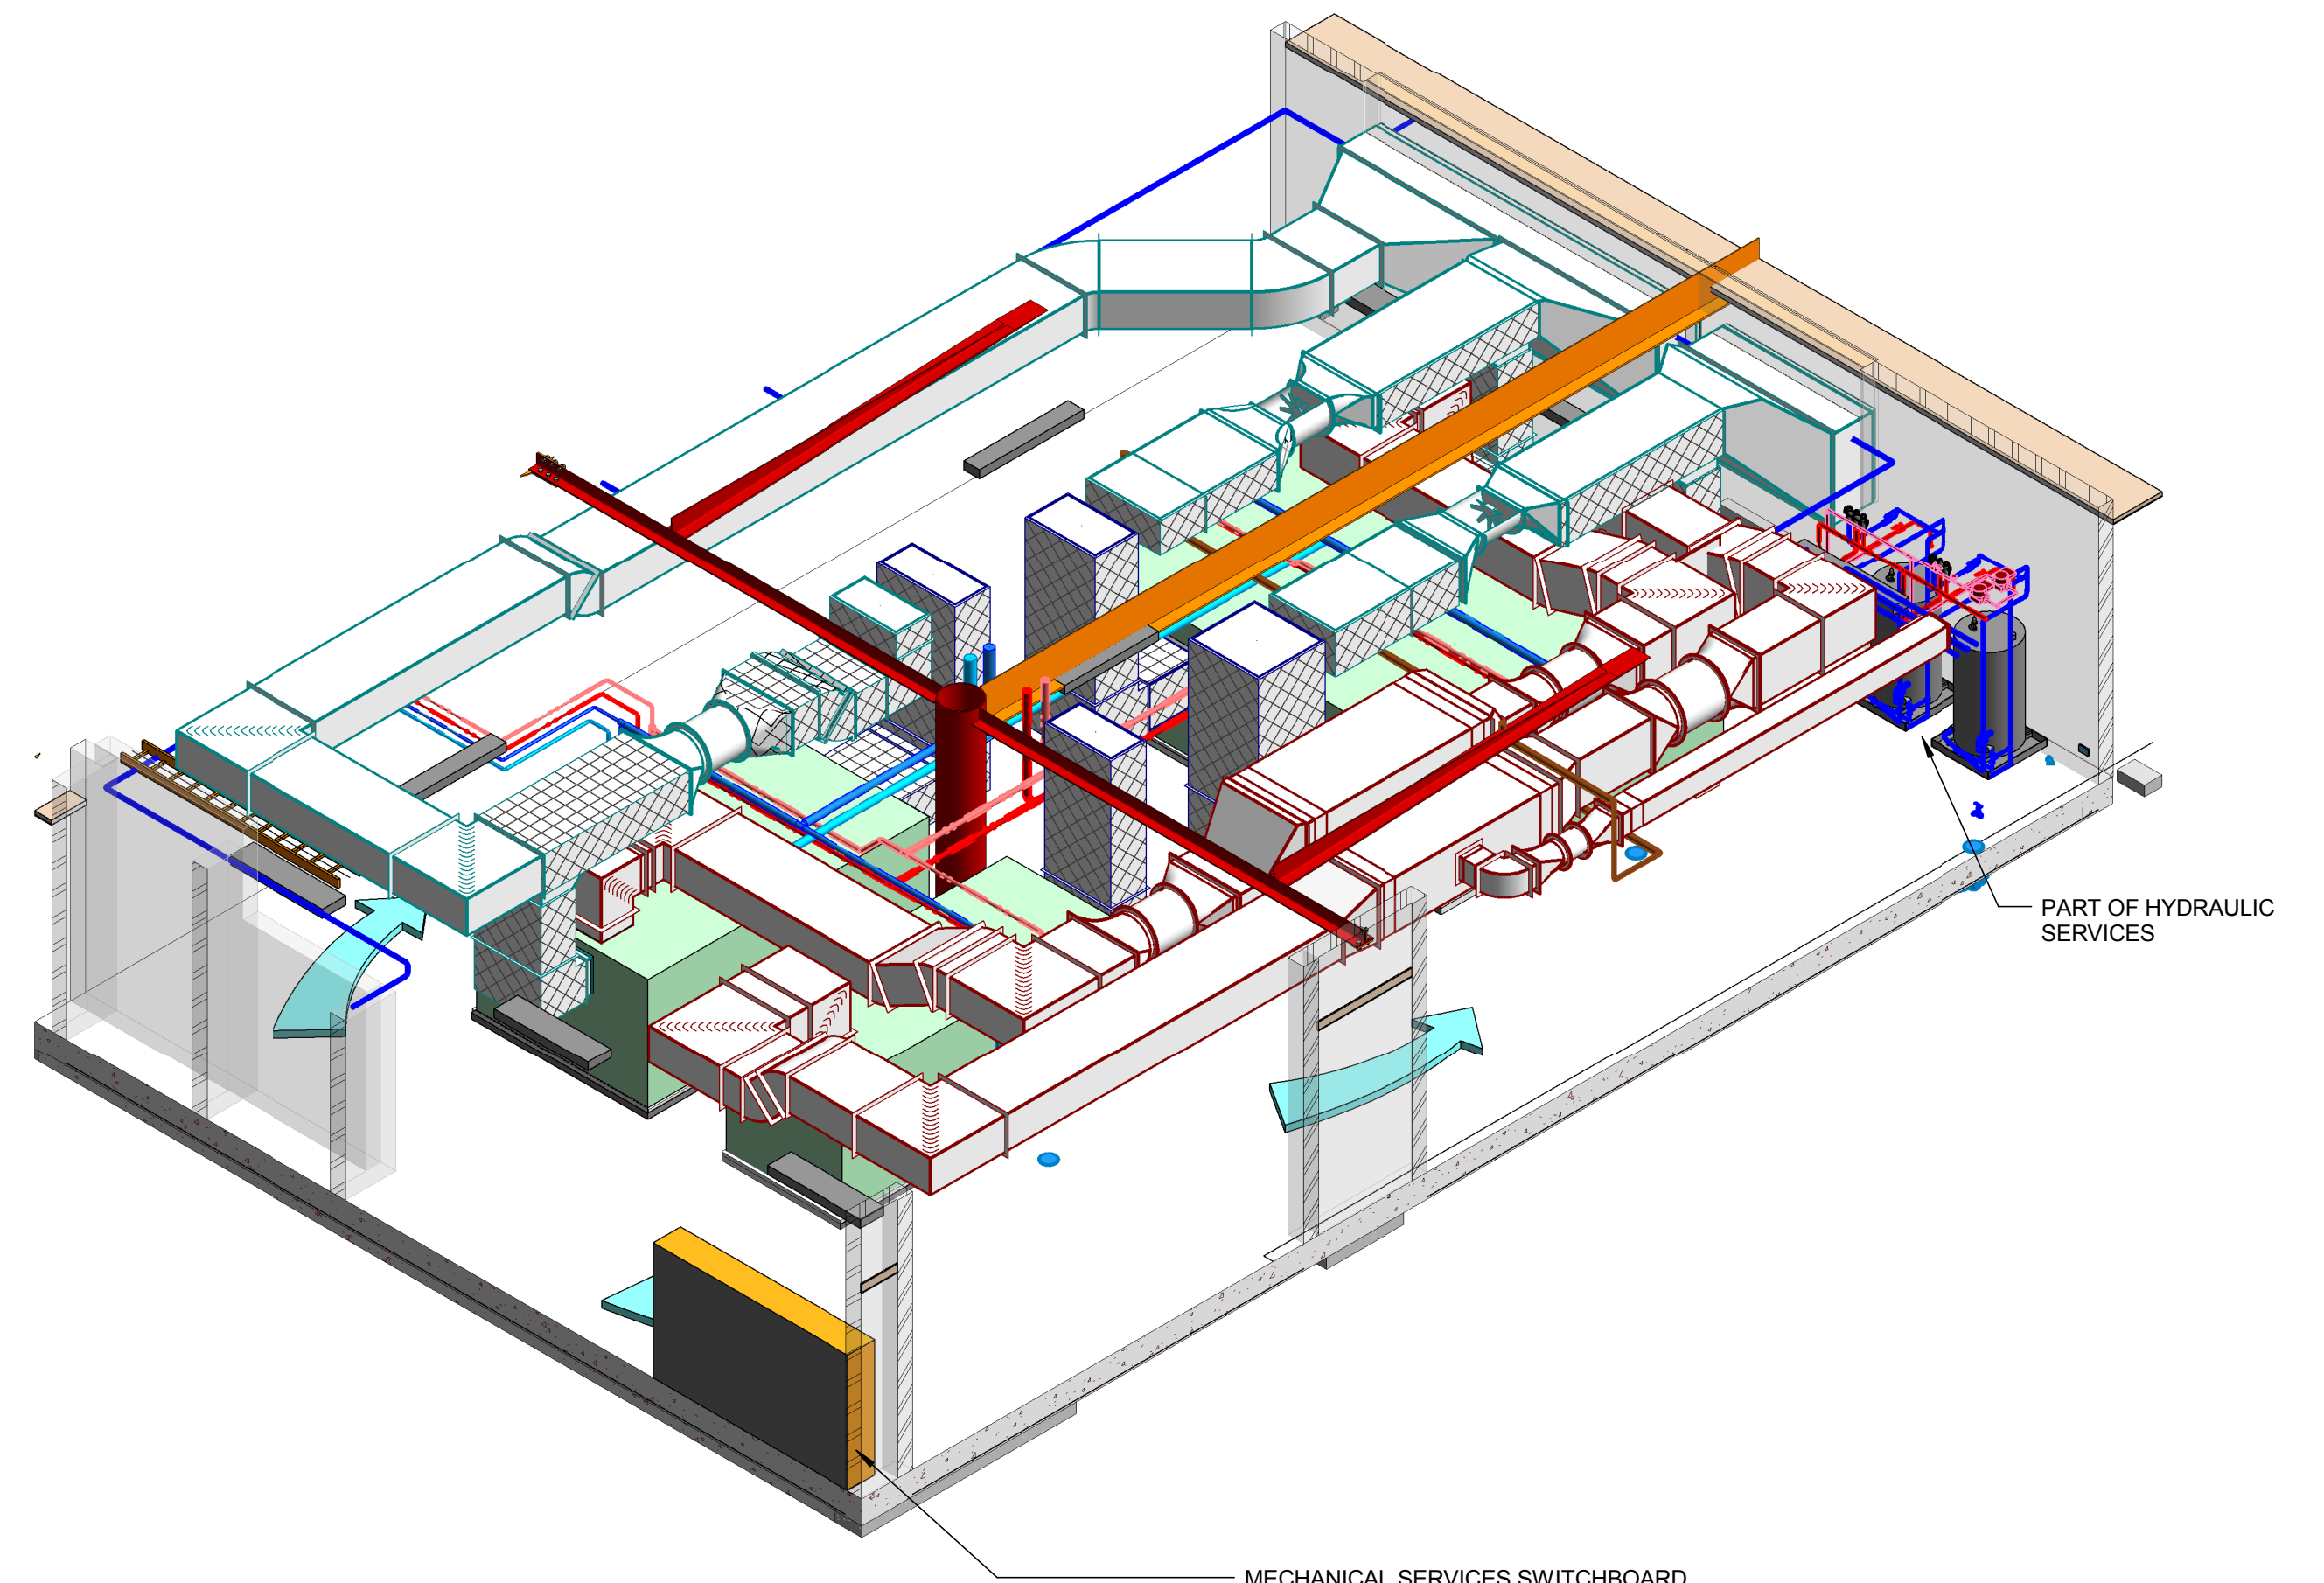

ISOMETRIC VIEW 2

FOR CONSTRUCTION

This drawing is confidential and shall only be used for the purpose of this project. The signing of this title block confirms the design and drafting of this project have been prepared and checked in accordance with the AECOM quality assurance system to ISO 9001-2000.

AECOM

CONSULTANT
AECOM New Zealand Limited
AECOM House, 8 Mahuhu Crescent
Auckland 1010, Auckland, NZ 1010
+64 9 967 9200 tel +64 9 967 9201 fax
www.aecom.com

WARREN AND MAHONEY

CONSULTANT
201 Victoria Street West
PO Box 91517
Auckland 1142
New Zealand
Phone + 64 9 309 4894

PROJECT
AUCKLAND AIRPORT - PIER B

CLIENT
Auckland Airport

SCALE

NOT TO SCALE

PROJECT MANAGEMENT INITIALS

MC	NF	SA
DESIGNER	CHECKED	APPROVED

ISSUE/REVISION

I/R	DATE	DESCRIPTION
0	23/12/2016	FOR CONSTRUCTION

PROJECT NUMBER

91345

SHEET TITLE

MECHANICAL SERVICES
TYPICAL MECHANICAL PLANT
ROOM GATE 17, 18 & 19
ISOMETRIC VIEWS
SHEET NUMBER

91345-ACM-DRG-ME-0071